

Republic of the Philippines
DEPARTMENT OF TRANSPORTATION AND COMMUNICATIONS



PROJECT TITLE:
CONSTRUCTION/RENOVATIONS OF TOILET FACILITIES FOR CAAP
(CAA. 12. CR. T1. A1. W1. L1. 2.), (CAA. 12. CR. T1. A1. W1. L1. 1. 0.)
(CAA. 12. CR. T1. D1. N1. L1. 2.), (CAA. 12. CR. T1. D1. N1. L1. 1. 0.)

LOCATION:
BISLIG AIRPORT
Bislig Surigao Del Sur, CARAGA/R12

Prepared by:
HERMINIANO R. HUELGAS
Acting Division Chief III
Infrastructure Development and Design Division

Submitted by:
EDGARDO L. COSTES
Assistant Director General II, ADMS

Recommending Approval:
GUILLERMO L. LEONARDO
O.I.C-Assistant Secretary for Project Management

Approved:
ATTY. EFREN C. MONCUPA
Undersecretary for Project Implementation and Special Concerns

Sheet Content:
PROPOSED TERMINAL PLAN
PLAN OF WATER PUMP AND PRESSURE TANK ASSEMBLY
DETAIL OF WATER PUMP AND PRESSURE TANK ASSEMBLY
EXHAUST FAN LAYOUT PLAN (TYPE I & TYPE II)



Republic of the Philippines
DEPARTMENT OF TRANSPORTATION
AND COMMUNICATIONS



PROJEC
**CONSTRUCTION/RENOVATIONS OF
TOILET FACILITIES FOR CAAP**

CAA. 12. CR. T1. A1. W1. L1. 1. CAA. 12. CR. T1. D1. N1. L1. 1.
CAA. 12. CR. T1. A1. W1. L1. 2. CAA. 12. CR. T1. D1. N1. L1. 2.
CAA. 12. CR. T1. A1. W1. L1. 0. CAA. 12. CR. T1. D1. N1. L1. 0.

LOCATION :
BISLIG AIRPORT
Bislig Surigao Del Sur, CAGARAGAN XII

Prepared by:

HERMINIANO R. HUELGAS
Acting Division Chief III,
Infrastructure Development and Design Division

Submitted by:

EDGARDO L. COSTES
Assistant Director General II,
Aerodrome Design and Management Division

Recommending Approval:

GUILLERMO L. LEONARDO
O.I.C-Assistant Secretary for
Project Management


Approved:

ATTY. EFREN C. MONCUPA
Undersecretary for Project
Implementation and Special Concerns



Sheet Content:




FEXISTING FLOOR PLAN
PROPOSED FLOOR PLAN

Sheet No.:
A **TS**

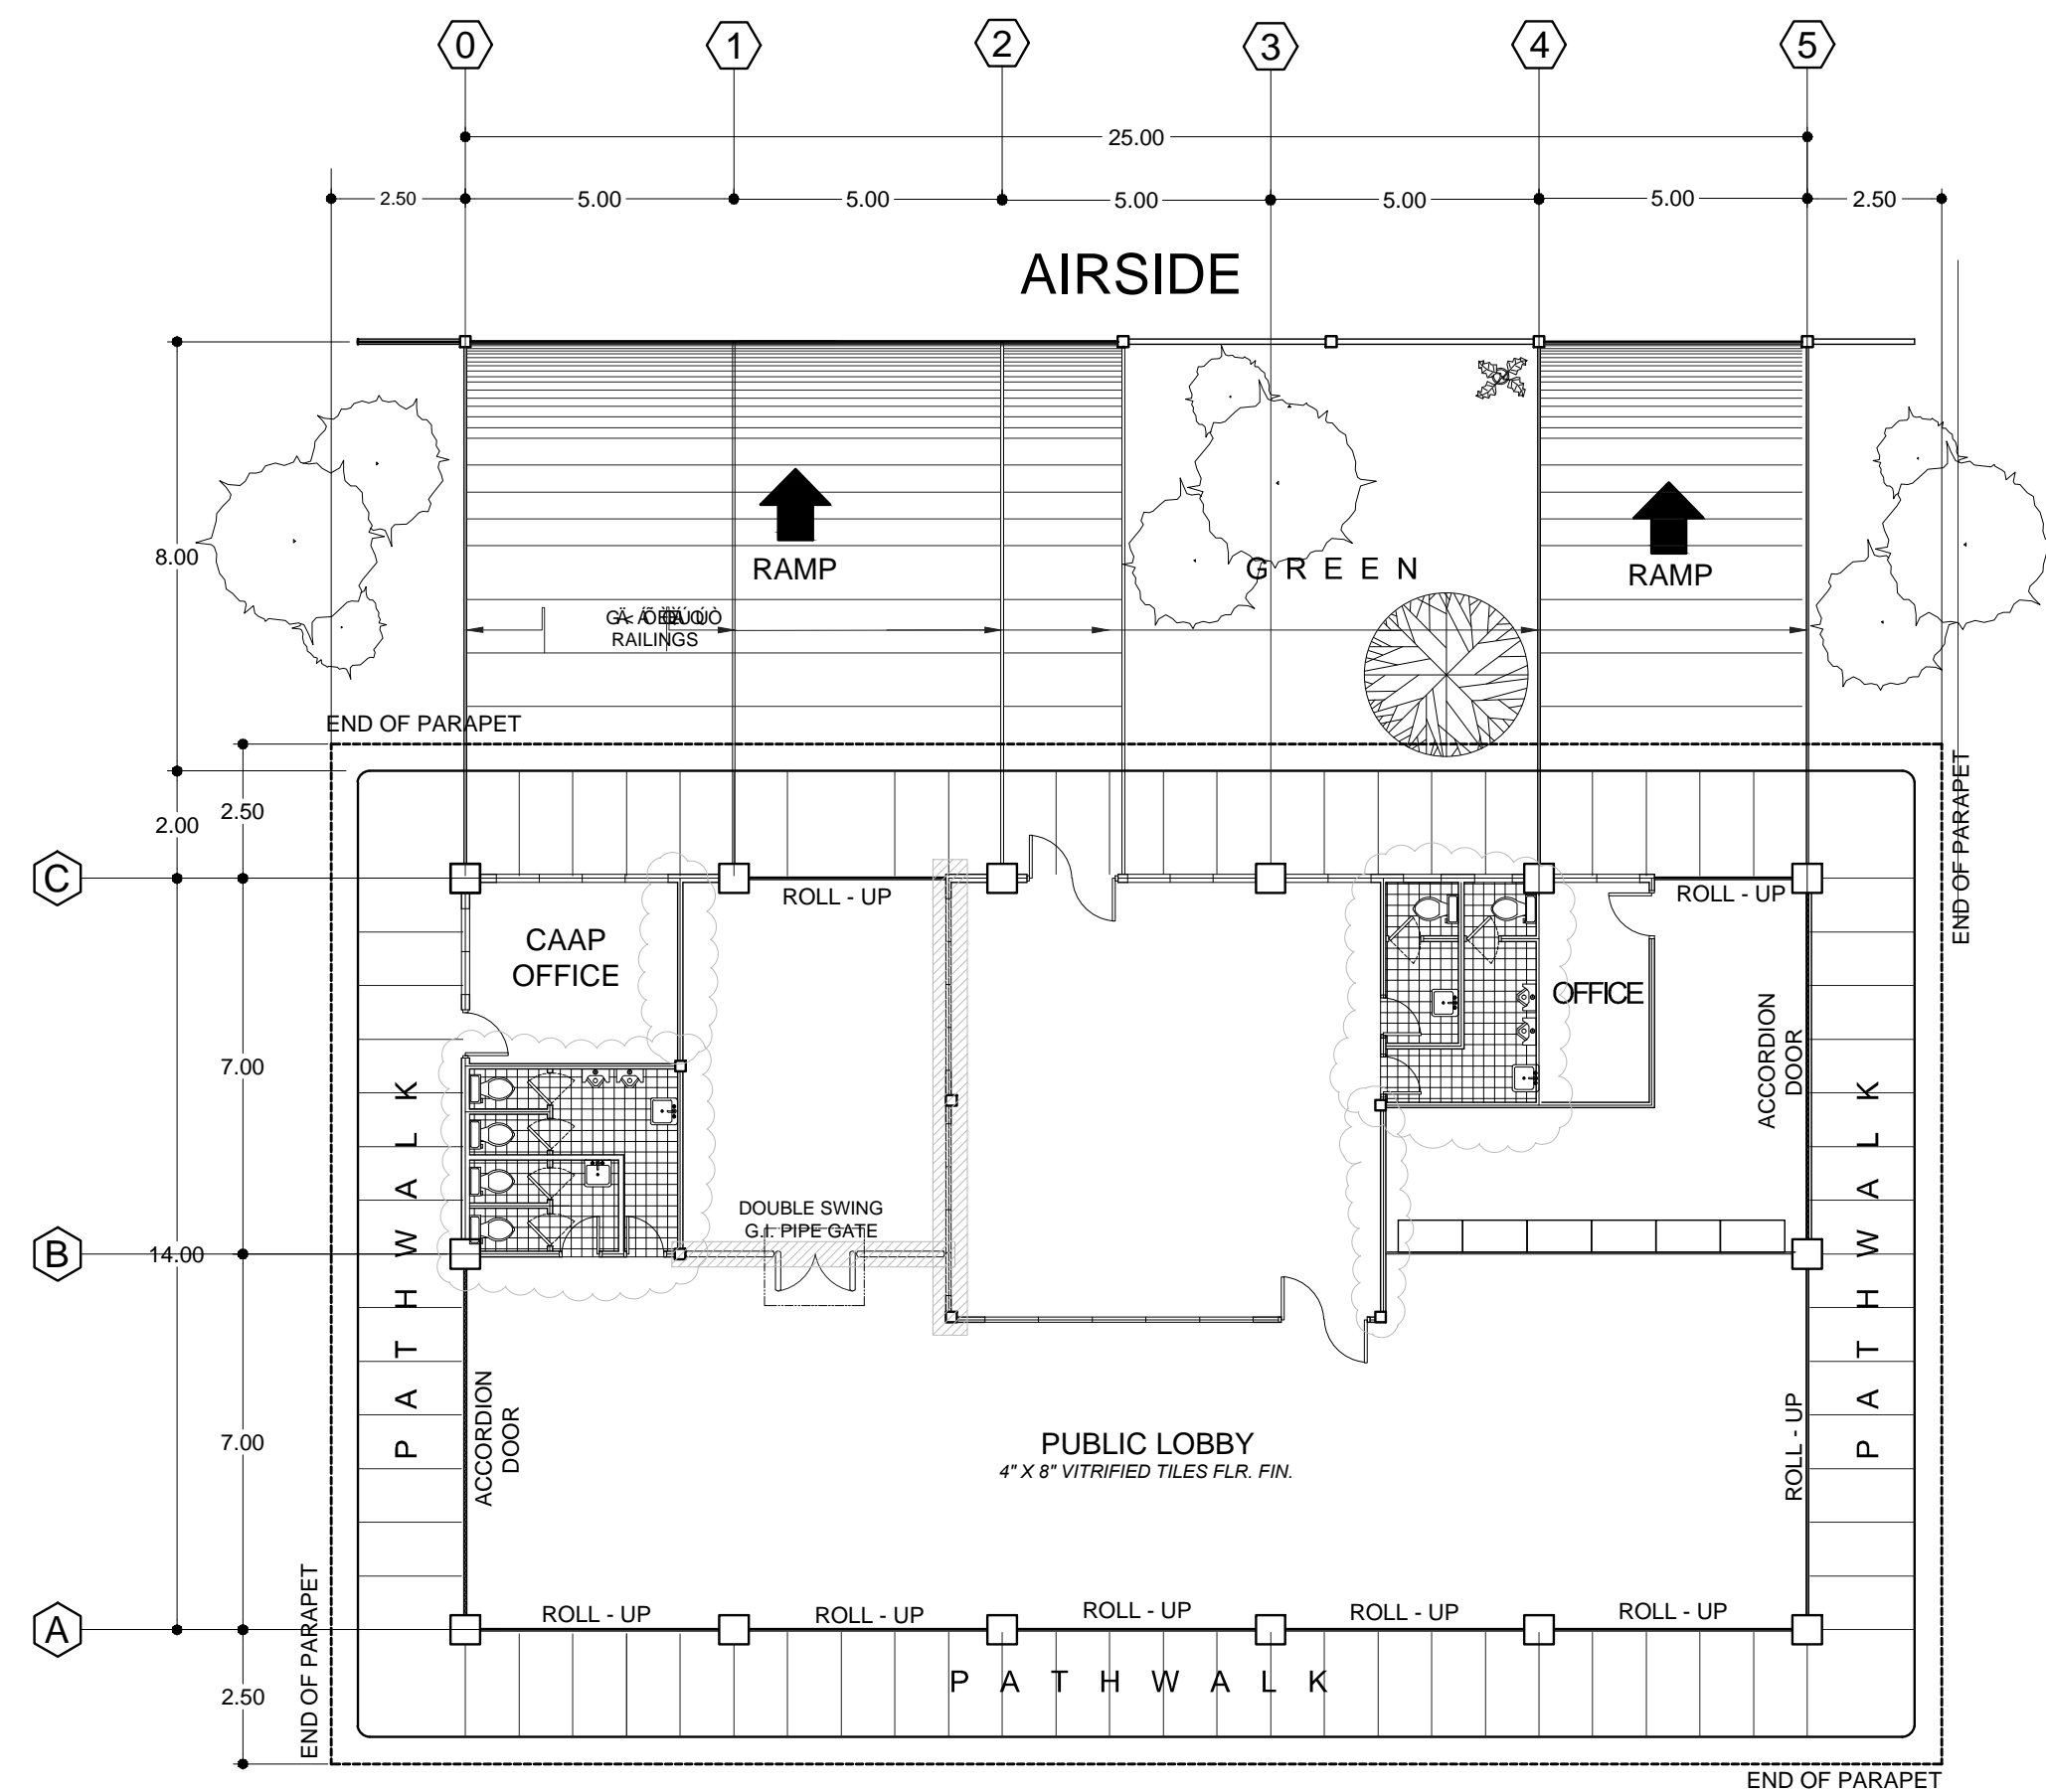


- LEGEND :
- AREA TO BE DEMOLISHED
 - CONSTRUCTION/ RE-CONSTRUCTION OF AFFECTED AREAS
 - RELOCATION OF DOORS & WINDOWS

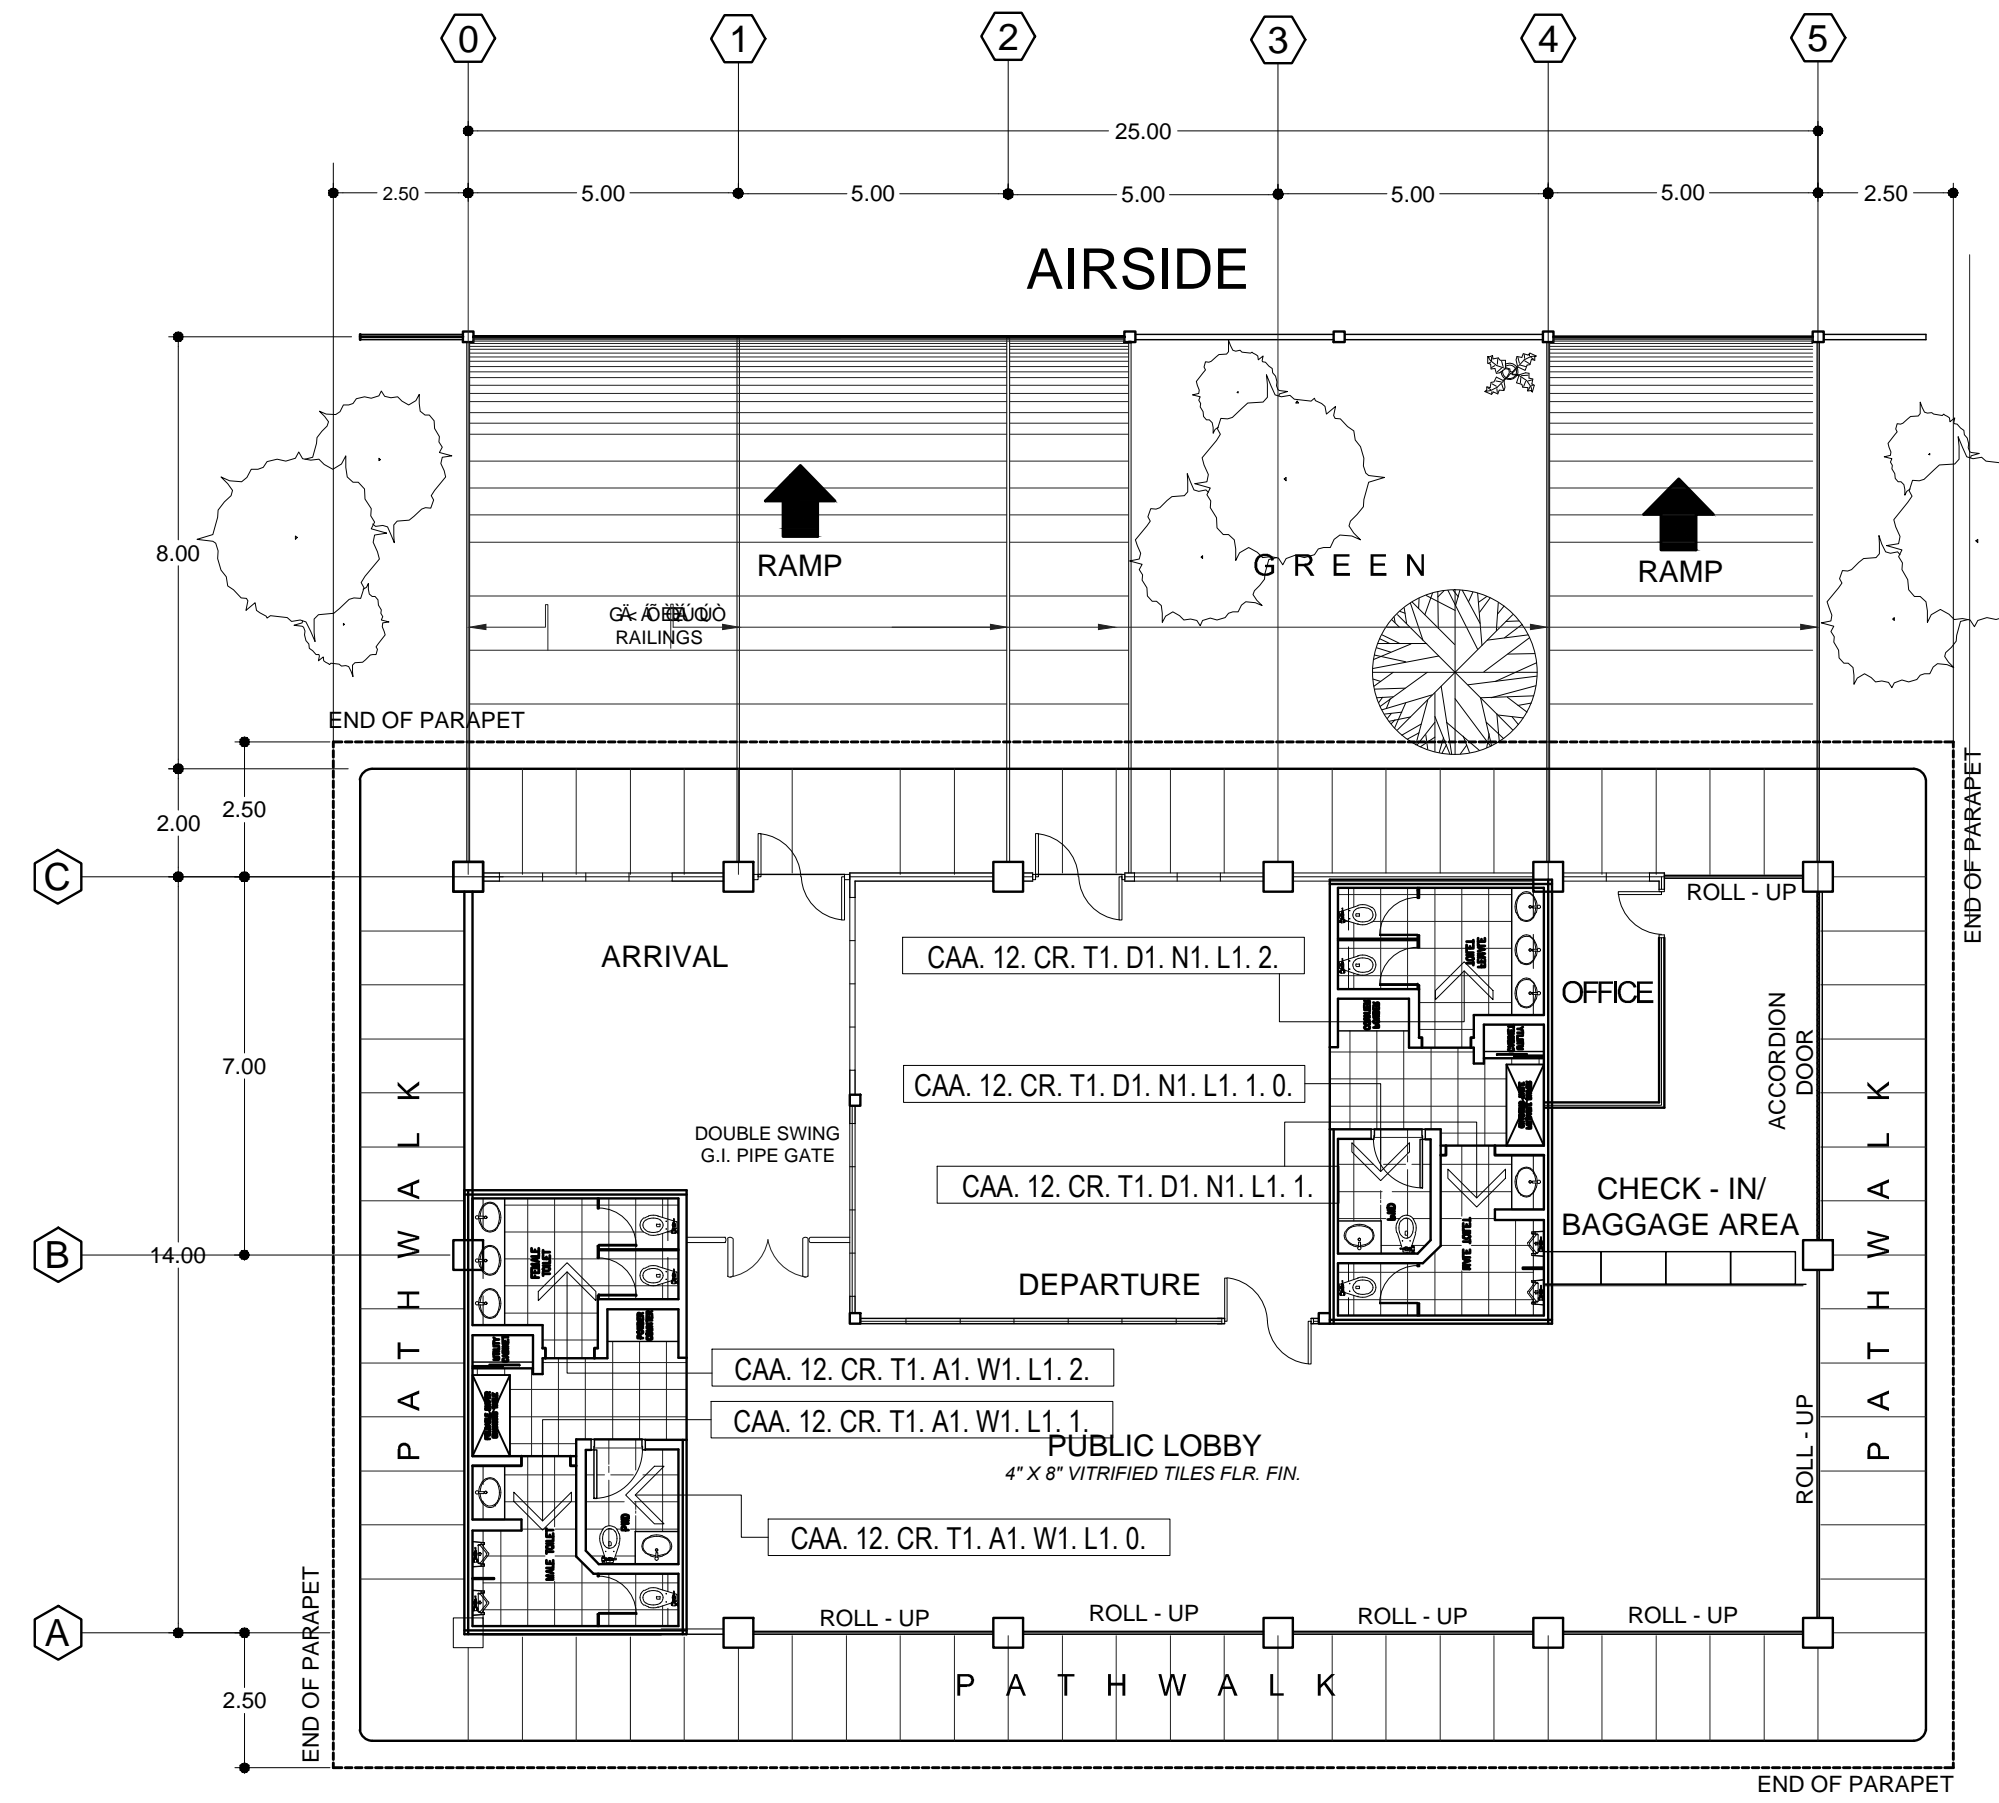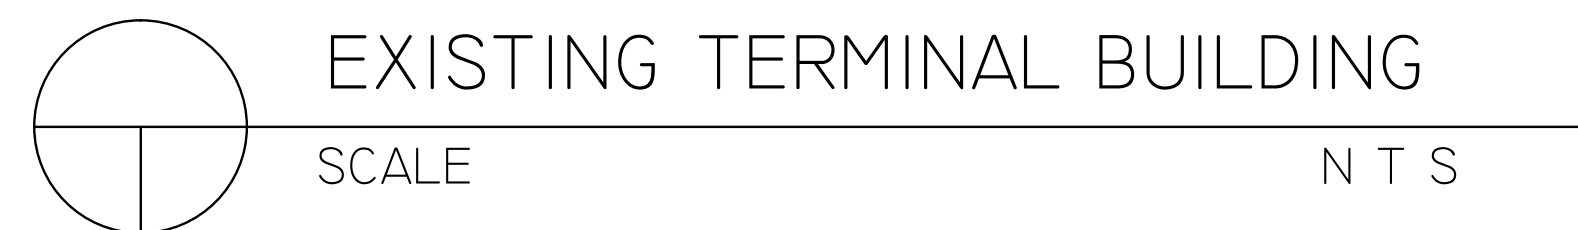

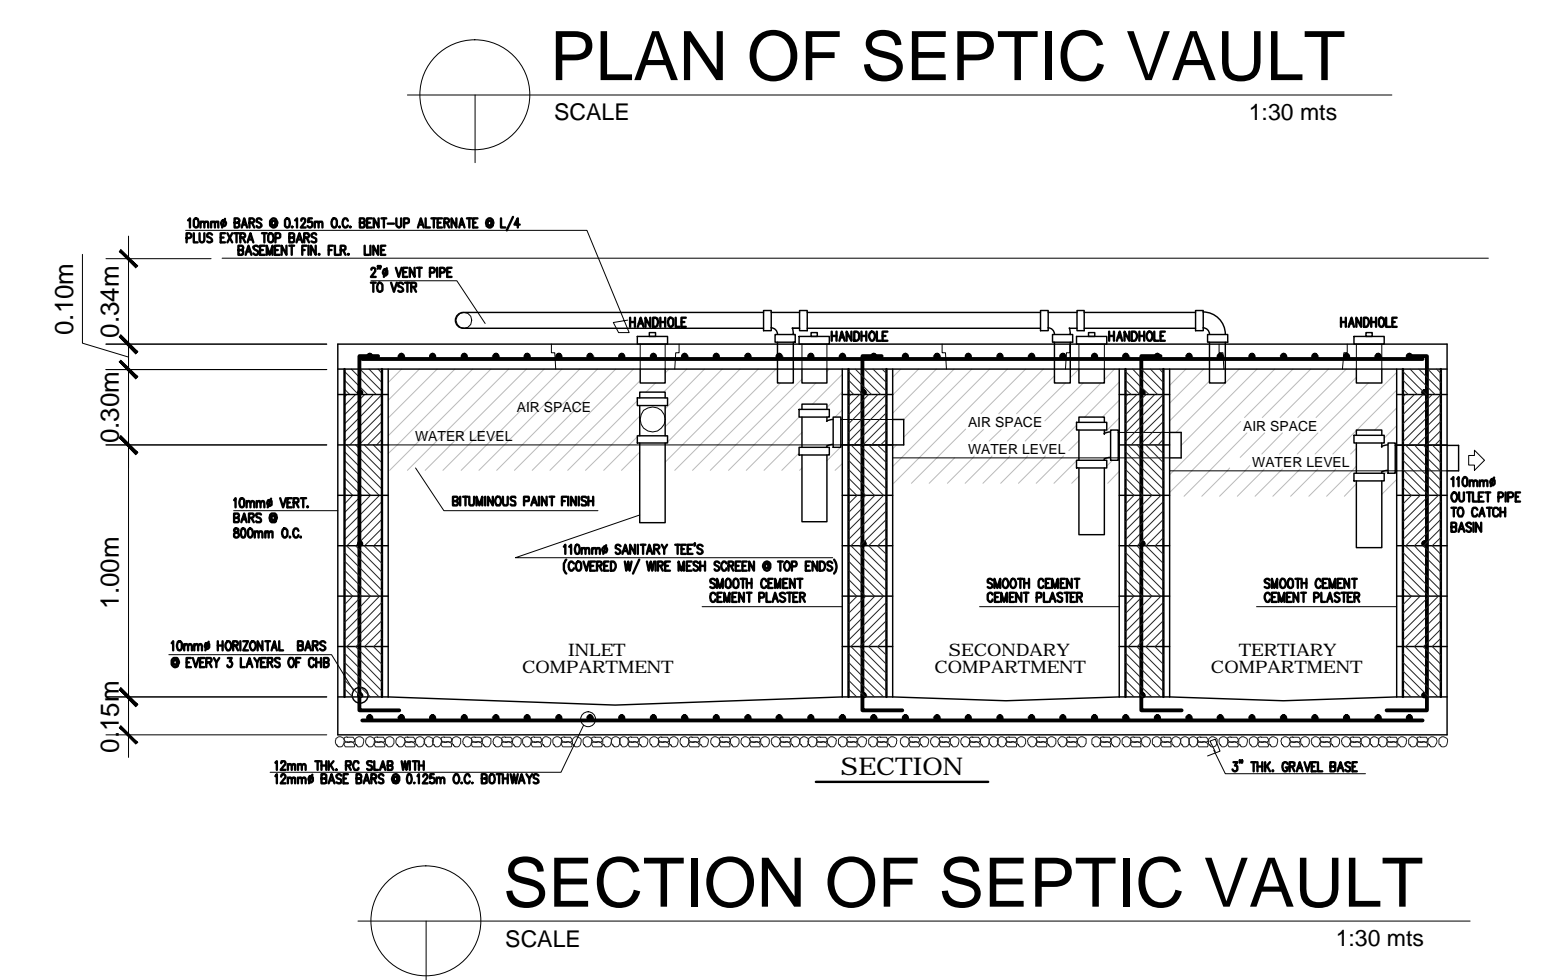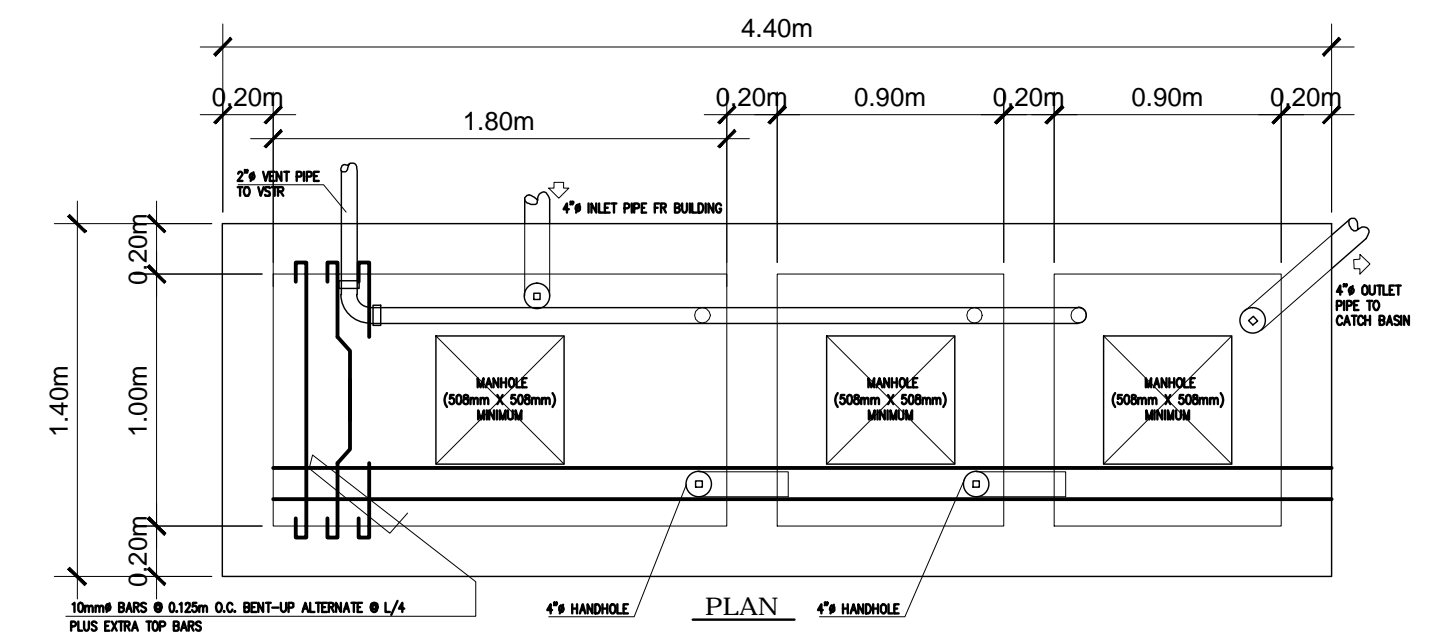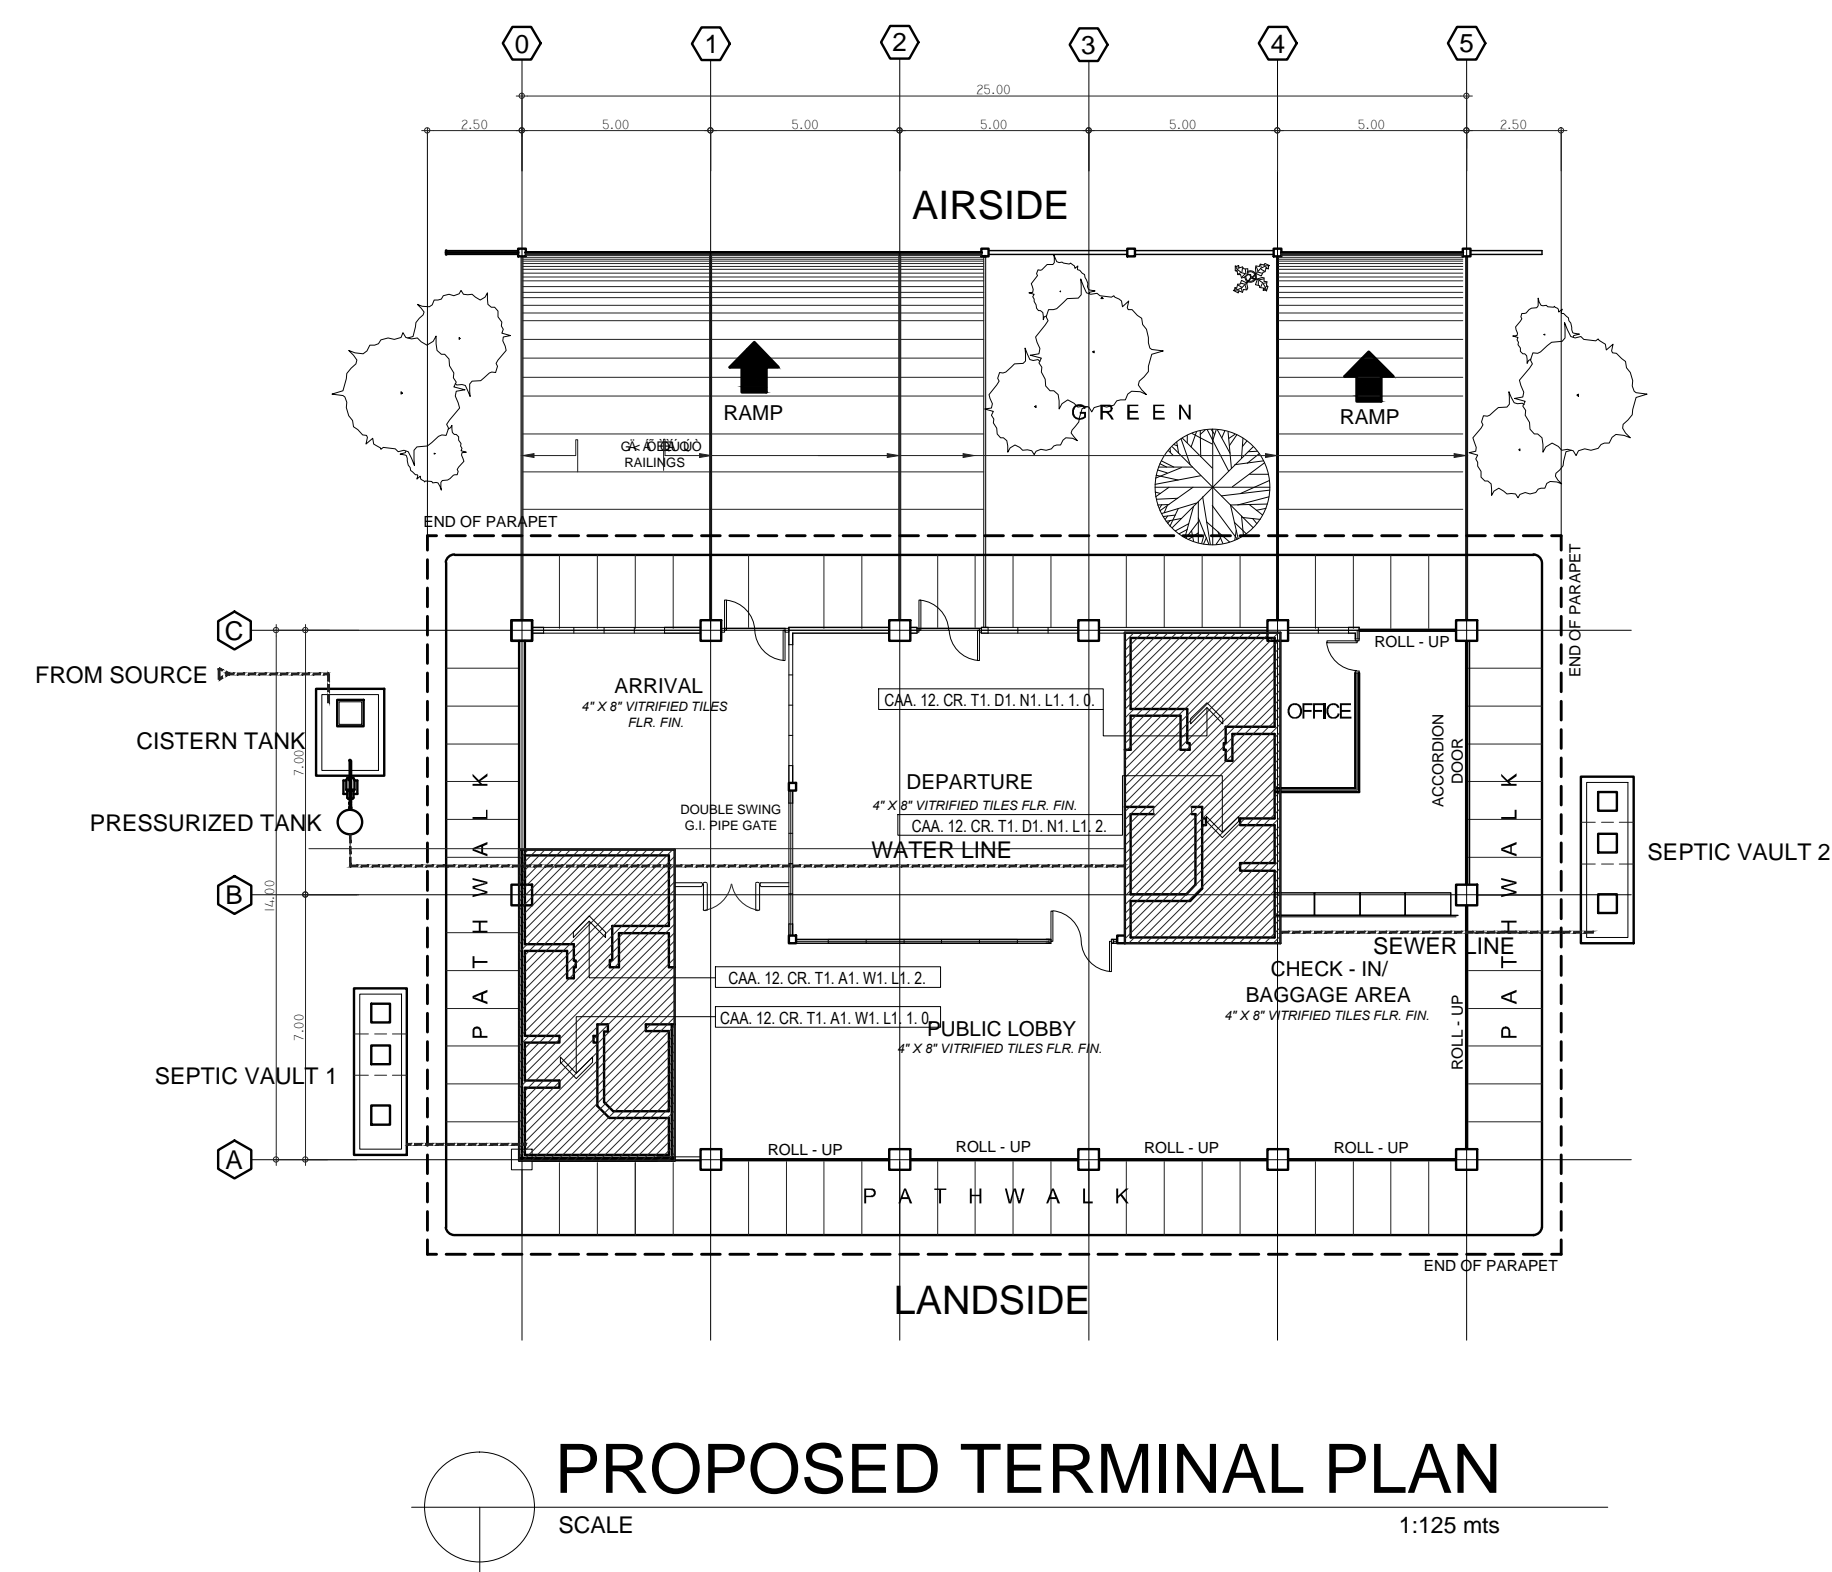

SPECIFICATION:

1. THE LOCATION OF SEPTIC VAULT/ PRESSURIZED TANK SHALL BE MORE THAN 3.0 METERS AWAY FROM THE BUILDING LINE.
2. THE DISTANCE OF SEPTIC VAULT FROM PROPOSED CISTERN SHALL BE 15 METERS AWAY.
3. WATER PIPE LINE AND SEWER LINE RUNNING PARALLEL IN DIRECTION SHALL HAVE A MINIMUM DISTANCE IN SEPARATION OF 0.50 METER AND AVOID INSTALLING WATER LINE BELOW SEWER LINE.
4. THE STANDARD PLUMBING PLANS (COLD WATER LINE AND SEWER LINE) SHALL RE-CONFIGURATED AND SHALL REVISED DEFENDING ON THE ORIENTATION OF TOILET PLANS.
5. THE CONSTRUCTION SHALL BE SUPERVISED BY A LICENSE PLUMBER AND SHALL BE COVERED BY NATIONAL PLUMBING CODE OF THE PHILIPPINES.

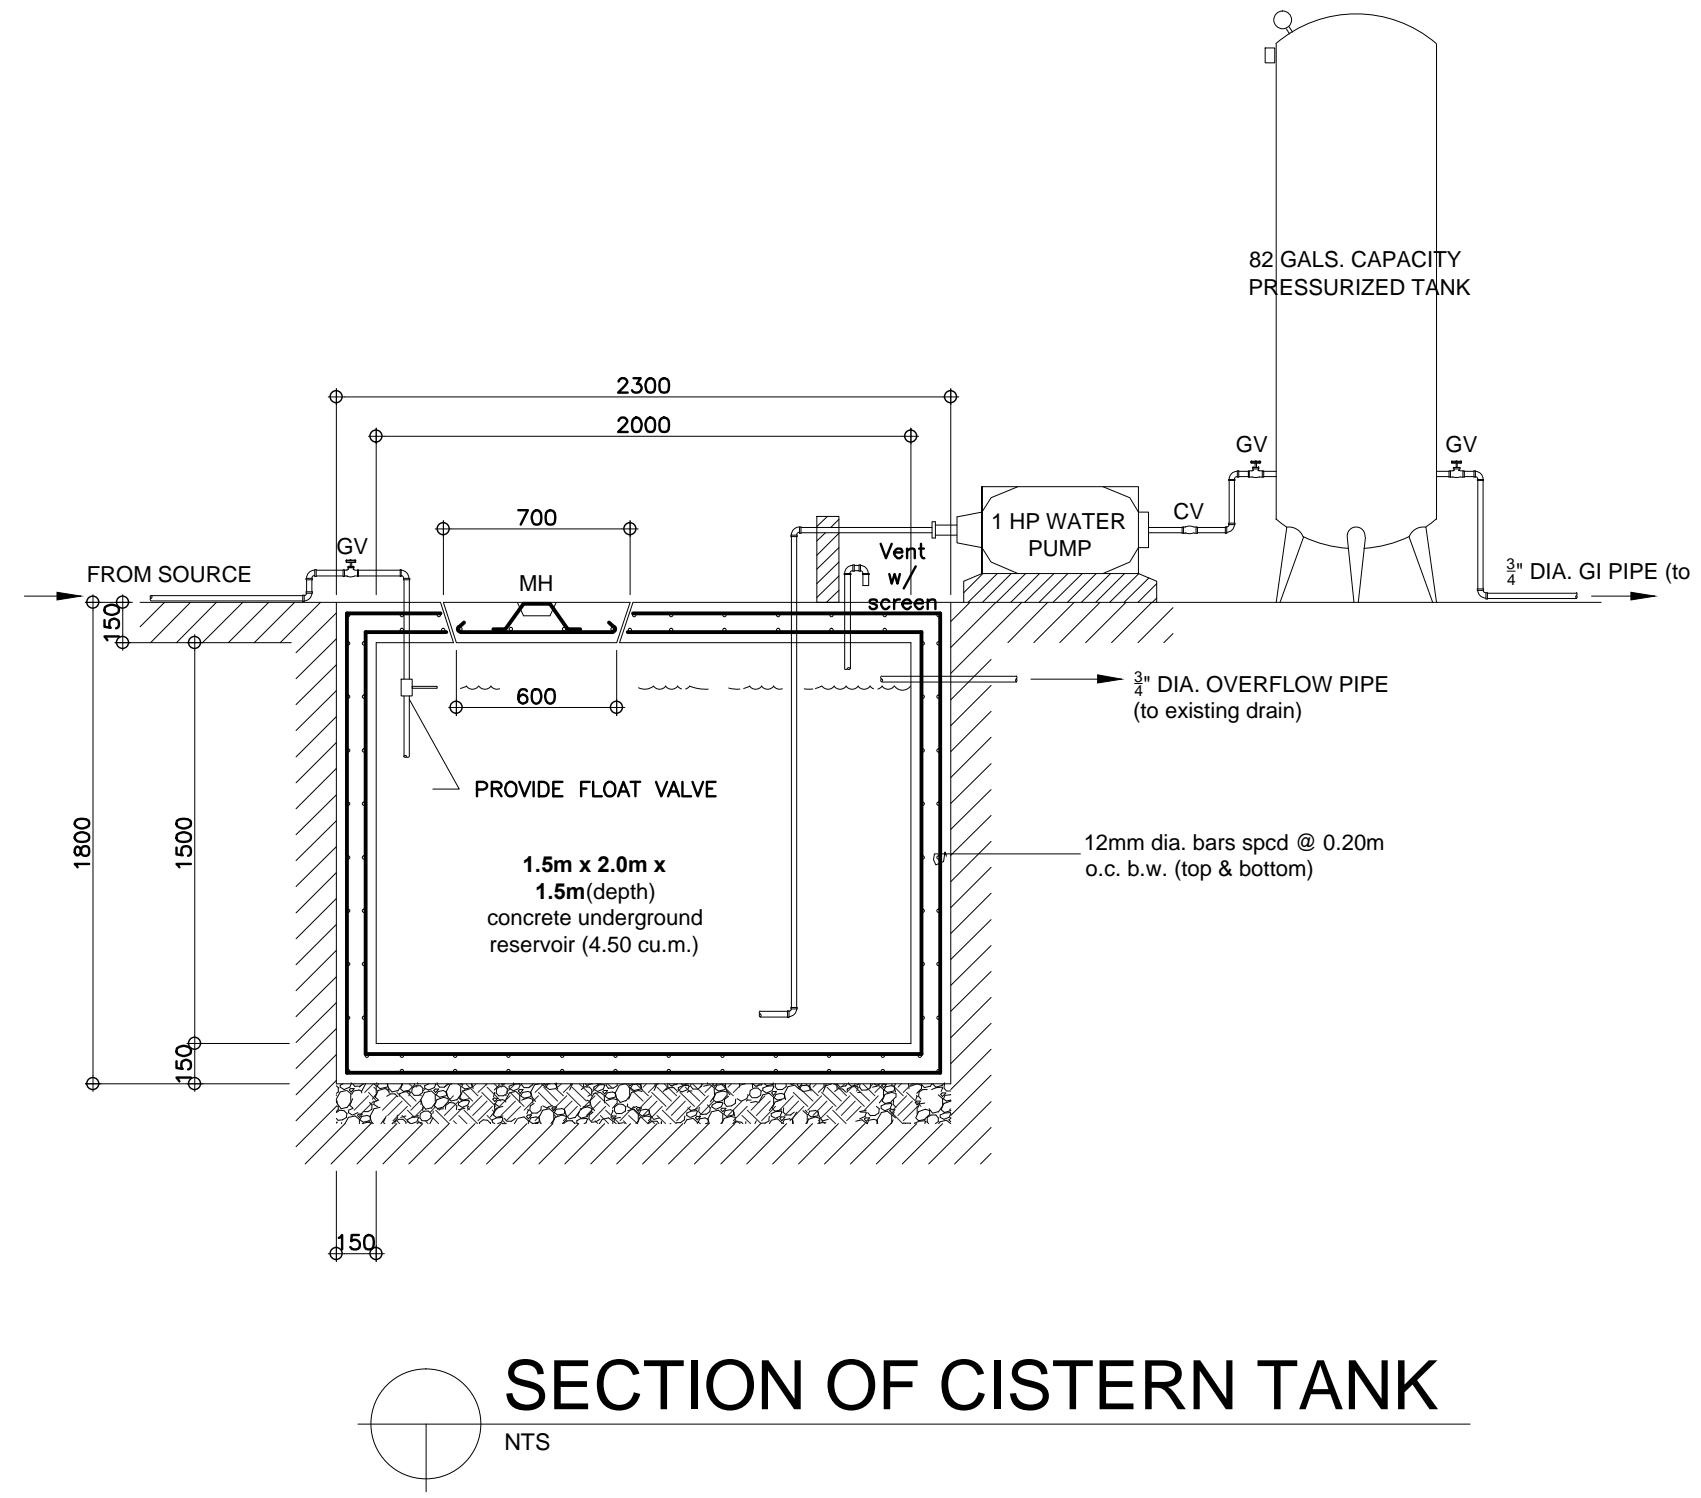

Republic of the Philippines
DEPARTMENT OF TRANSPORTATION
AND COMMUNICATIONS



REPUBLIC OF THE PHILIPPINES
DEPARTMENT OF TRANSPORTATION AND COMMUNICATIONS
CIVIL AVIATION AUTHORITY OF THE PHILIPPINES

PROJECT NAME :
**CONSTRUCTION/RENOVATIONS
OF TOILET FACILITIES FOR CAAP**
(CAA 12 CR. T1. D1. N1. L1. 1.0) (CAA 12 CR. T1. D1. N1. L1. 1.0)
(CAA 12 CR. T1. A1. W1. L1. 2.) (CAA 12 CR. T1. A1. W1. L1. 1.0)

LOCATION :
BISLIG AIRPORT
Bislig Surigao Del Sur, CARAGA/R12

Prepared by:
HERMINIANO R. HUELGAS
Acting Division Chief III
Infrastructure Development and Design Division

Submitted by:
EDGARDO L. COSTES
Assistant Director General II, ADMS

Recommending Approval:
GUILLERMO L. LEONARDO
O.I.C-Assistant Secretary for
Project Management

Approved:
ATTY. EFREN C. MONCUPA
Undersecretary for Project
Implementation and Special Concerns

Sheet Content:
PROPOSED TERMINAL PLAN
SECTION OF CISTERN TANK
PLAN OF SEPTIC VAULT
SECTION OF SEPTIC VAULT
SPECIFICATION